

www.romtec.com

info@romtec.com



18240 North Bank Rd., Roseburg, OR 97470

541-496-3541 fax: 541-496-0803

QUOTE #

Date: 10/26/05

GOVERNMENT QUOTATION - Building Only

Job:

Contractor: TOWN OF PELHAM-PARKS & REC.

Contact: DARREN MCCARTHY

Address: 6 VILLAGE GREEN

City: PELHAM

State: NH

Zip: 03076-3172

Phone: 603-635-2721

Fax:

Mobile:

E-mail: dmccarthy@pelhamweb.com

Agency/ Owner:

Architect/

Engineer:

Contact:

Address:

City:

State - Zip:

Phone:

Fax:

Mobile:

E-mail:

Project

Location:

 **CLICK HERE** for photos, drawings & product info at www.romtec.com.

TERMS-GOVERNMENT: Net 35-day from date of shipment. **TERMS-CONTRACTOR:** Romtec Fast-Pay Discount offered with pre-payment 7 days prior to shipping with Check/Visa/Mastercard/American Express or COD-Certified Funds. Net 35-day terms may be considered with approved payment bond and credit approval by Romtec accounting department. **Romtec Fast-Pay Discount is not available with net 35-day terms.**

Quantity	Model	Description	Comm. Price	Extension
1	2084	Value/Concrete - Sierra IV Multi-User Restroom with 10' Concession & Storage Rooms	\$73,602	\$73,602.00
		Roofing: dark brown mocha metal, unless otherwise specified. Exterior:split face concrete, unless otherwise specified.		\$0.00
1	-A	China Plumbing Fixture Pkg - S4MUcs (w/floor mount toilets)	\$4,595	\$4,595.00
1	-C	Electrical Fixture Pkg - S4MUcs (single-phase)	\$2,590	\$2,590.00
1	-E	Hot Water Pkg. (20 gallon electric)	\$637	\$637.00
1		Sierra IV Multi-user Restroom with Concession Accessory Kit: 2-roll white steel toilet paper dispenser (4), restroom signs-M/W (2 ea.), Bradley 583 seat cover dispenser (4), Bradley 6562 soap dispenser (3), Bradley 251-33 paper towel dispenser (3), Bradley 377 waste receptacle (2), Bradley 4722-15 sanitary napkin receptacle (3)	\$1,622	\$1,622.00
				\$0.00
SUBTOTAL				\$83,046.00
GOVERNMENT DISCOUNT: Available to state, county, city and other agencies. Requires purchase order placed by agency to Romtec. NOTE: Discount available to contractor through Romtec Fast-Pay Terms (pre-payment or COD certified funds).				-\$4,152.30
Structural Engineering Fee			\$1,200.00	\$1,200.00
2	Shipping & Handling From Roseburg, OR to: Pelham, NH		Zip Code:	\$11,988.00
TOTAL				\$92,081.70

A COMPLETE SET OF STAMPED PLANS, INCLUDING FOOTING & FOUNDATION DETAILS, IS INCLUDED WITH BUILDING PURCHASE.

*** SPECIAL INSTRUCTIONS:**

* All prices listed above are F.O.B. Roseburg, OR, freight prepaid and added.

* This quote is effective for 90 days from above date; thereafter all prices are subject to change without notice.

* There is 15% restocking fee on all returned items.

This quotation is subject to the terms and conditions listed on the second sheet of this form (Click Terms tab below).

Bernie Eatherton

Authorized Signature

10/26/2005

Date

www.romtec.com

info@romtec.com

Date: 10/26/05

Job:

Contractor: TOWN OF PELHAM-PARKS & REC

Contact: DARREN MCCARTHY

Address: 6 VILLAGE GREEN

City: PELHAM

State: NH

Zip: 03076-3172

Phone: 603-635-2721

Fax:

Mobile

E-mail: dmccarthy@pelhamweb.com

 **CLICK HERE** for photos, drawings & product info at www.romtec.com.

18240 North Bank Rd., Roseburg, OR 97470

541-496-3541 fax: 541-496-0803

QUOTE #

Agency/ Owner:

Architect/

Engineer:

Contact:

Address:

City:

State - Zip:

Phone:

Fax:

Mobile:

E-mail:

Project

Location:

TERMS-GOVERNMENT: Net 35-day from date of shipment. **TERMS-CONTRACTOR:** Romtec Fast-Pay Discount offered with pre-payment 7 days prior to shipping with Check/Visa/Mastercard/American Express or COD-Certified Funds. Net 35-day terms may be considered with approved payment bond and credit approval by Romtec accounting department. **Romtec Fast-Pay Discount is not available with net 35-day terms.**

Quantity	Model	Description	Comm. Price	Extension
1	2647	24'-0" x 22'-0" SplitLok Concrete Building with 3' x 7' single man door and 8' x7' roll-up door	\$52,079	\$52,079.00
		Concrete walls: 8" CMU (steel-reinforced/concrete filled), brown split-face exterior (unless specified otherwise). Insulated roof: 6" steel rafter frame with hi-rib metal roofing (mocha dark brown color unless specified otherwise) over 3/4" plywood exterior sheathing. Interior ceiling finished with white FRP over 7/16" OSB. Interior walls finished with FRP over CMU.		\$0.00
				\$0.00
			SUBTOTAL	\$52,079.00
			GOVERNMENT DISCOUNT: Available to state, county, city and other agencies. Requires purchase order placed by agency to Romtec. NOTE: Discount available to contractor through Romtec Fast-Pay Terms (pre-payment or COD certified funds).	-\$2,603.95
Structural Engineering Fee			\$1,200.00	\$1,200.00
1.5	Shipping & Handling From Roseburg, OR to: Pelham, NH		Zip Code:	\$9,390.00
			TOTAL	\$60,065.05

A COMPLETE SET OF STAMPED PLANS, INCLUDING FOOTING & FOUNDATION DETAILS, IS INCLUDED WITH BUILDING PURCHASE.

*** SPECIAL INSTRUCTIONS:**

- * All prices listed above are F.O.B. Roseburg, OR, freight prepaid and added.
- * This quote is effective for 90 days from above date; thereafter all prices are subject to change without notice.
- * There is 15% restocking fee on all returned items.
- * This quotation is subject to the terms and conditions listed on the second sheet of this form (Click Terms tab below).

Bernie Eatherton


Authorized Signature

10/26/2005

Date

SCHEDULE OF VALUES

[illegible]

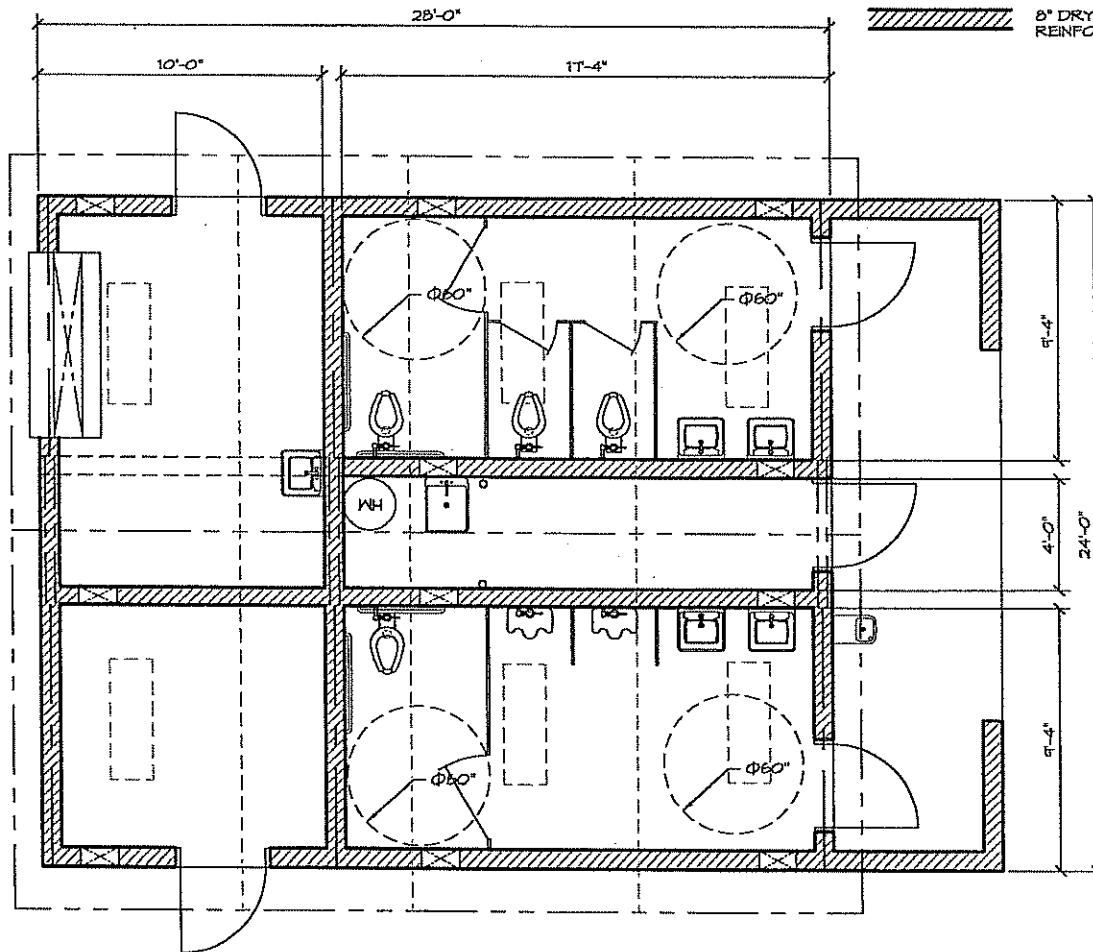

WALL TYPE SCHEDULE

8" DRY STACK CMU WALL
REINFORCED & GROUT FILLED

FINAL DRAFT
NOT FOR
CONSTRUCTION

1

FLOOR PLAN

SCALE: 1/4" = 1'-0"




PRELIMINARY

PROJECT BUILDING	PROJECT LOCATION	SHEET TITLE: FLOOR PLAN
MODEL: 2084		
DATE: MM/DD/04		
REVISIONS		
REV.	DATE	BY
ISSUED BY: JP		

SHEET NO.

A2.1

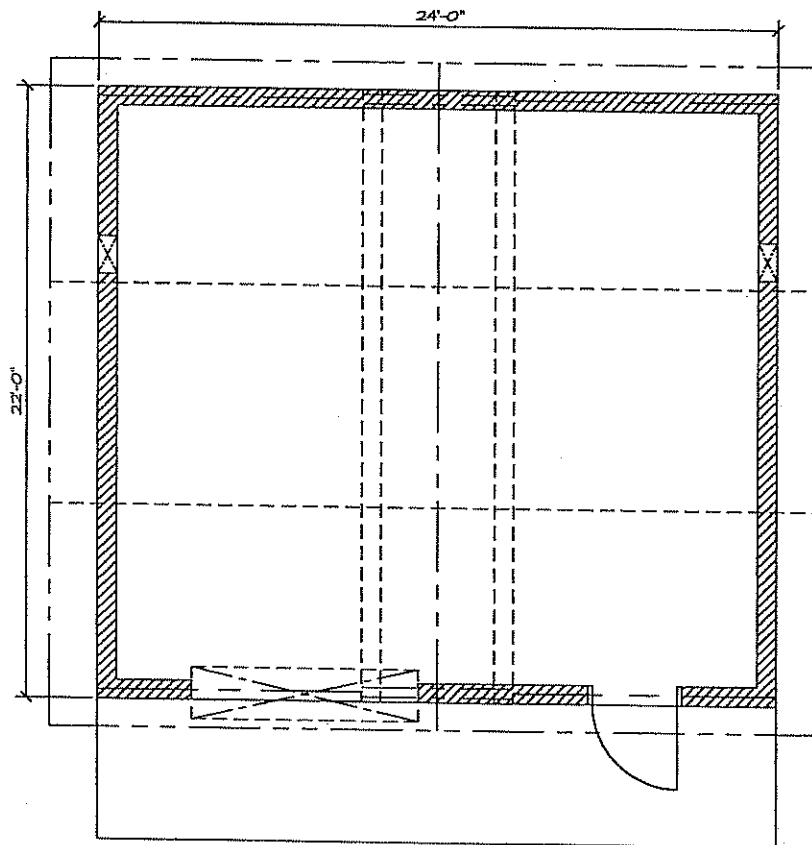

1

FLOOR PLAN

SCALE: 1/4" = 1'-0"



WALL TYPE SCHEDULE



8" DRY STACK CMU WALL
REINFORCED & GROUT FILLED


FINAL DRAFT
NOT FOR
CONSTRUCTION

PROJECT BUILDING		PROJECT LOCATION		SHEET TITLE FLOOR PLAN	
MODEL		2647		DATE: MM/DD/04	
REVISIONS		REV		DATE	
BY		DATE		BY	
DRAWN BY		JP			

SHEET NO.

A2.1

PRELIMINARY

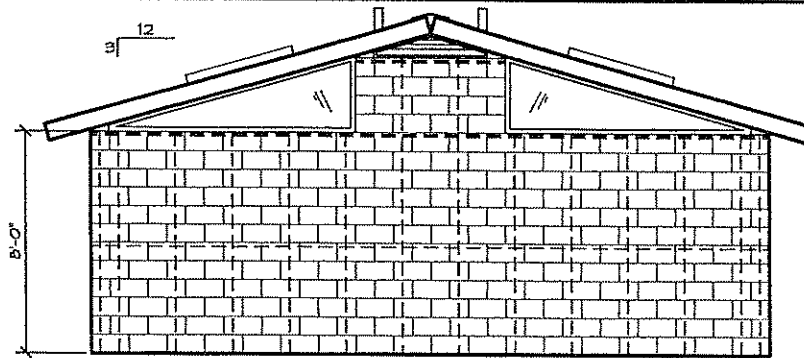

1

WEST ELEVATION

SCALE: 1/4" = 1'-0"

2

NORTH ELEVATION

SCALE: 1/4" = 1'-0"


FINAL DRAFT
NOT FOR
CONSTRUCTION

PROJECT:		ROMTEC	
SHEET TITLE:		EXTERIOR ELEVATIONS	
DATE:			
REVISIONS			
REV.	DATE:	BY	
DRAWN BY:			

PRELIMINARY

SHEET NO.

A3.2

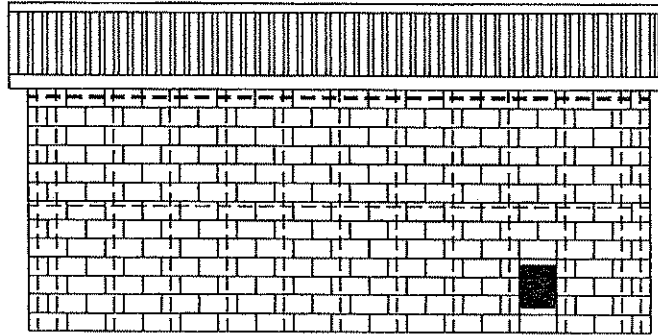

1

EAST ELEVATION

SCALE: 1/4" = 1'-0"

2

NORTH ELEVATION


SCALE: 1/4" = 1'-0"

FINAL DRAFT
NOT FOR
CONSTRUCTION


PROJECT:		SHEET TITLE: EXTERIOR ELEVATIONS		ROMTEC DESIGN	
DATE:		REVISIONS		DRAWN BY:	
REV.	DATE:	BY:			

PRELIMINARY

SHEET NO.
A3.2

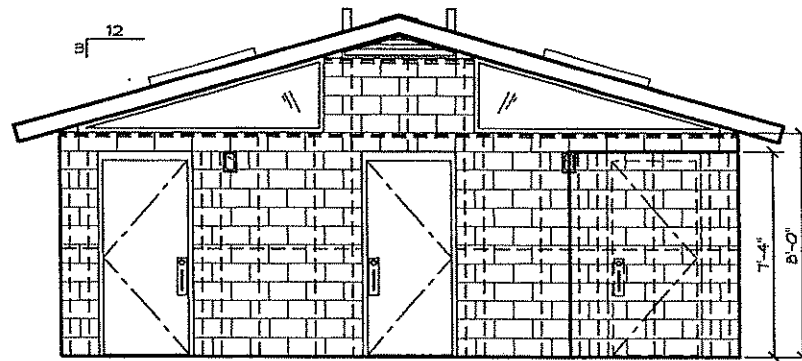

① EAST ELEVATION
SCALE: 1/4" = 1'-0"

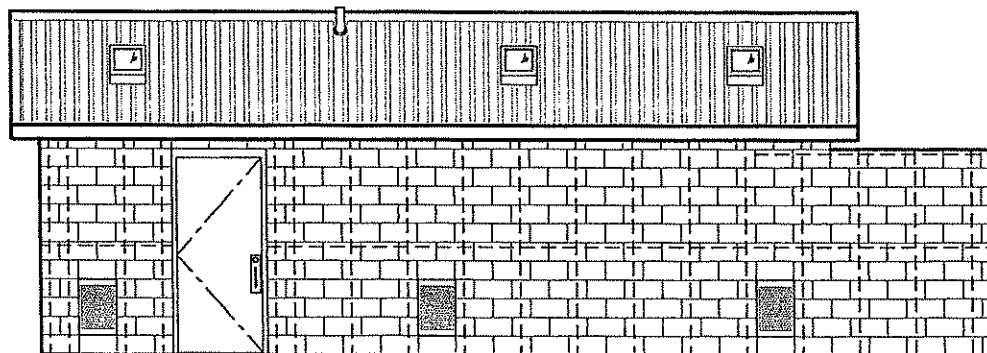

② SOUTH ELEVATION
SCALE: 1/4" = 1'-0"


PRELIMINARY

FINAL DRAFT
NOT FOR
CONSTRUCTION

PROJECT:			ROMTEC		
DATE:			SHEET TITLE: EXTERIOR ELEVATIONS		
REVISIONS					
REV.	DATE:	BY			
DRAWN BY:					

SHEET NO.

A3.1

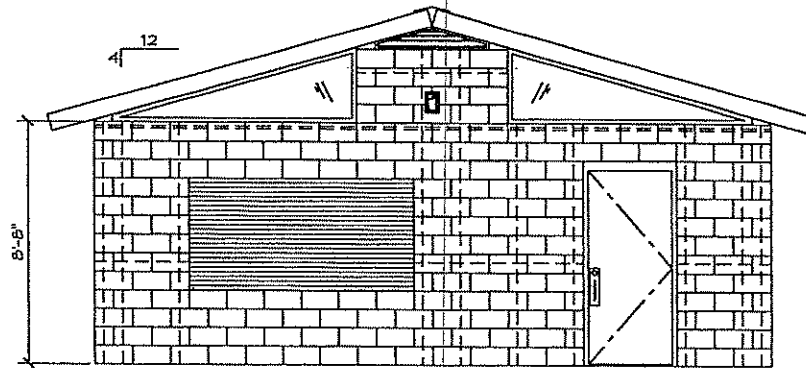

1

SOUTH ELEVATION

SCALE: 1/4" = 1'-0"

2

WEST ELEVATION





SCALE: 1/4" = 1'-0"




FINAL DRAFT
NOT FOR
CONSTRUCTION

PROJECT:		ROMTEC UTILITIES	
SHEET TITLE:		EXTERIOR ELEVATIONS	
DATE:			
REVISIONS			
NO.	DATE	BY	


PRELIMINARY

 SHEET NO.
A3.1

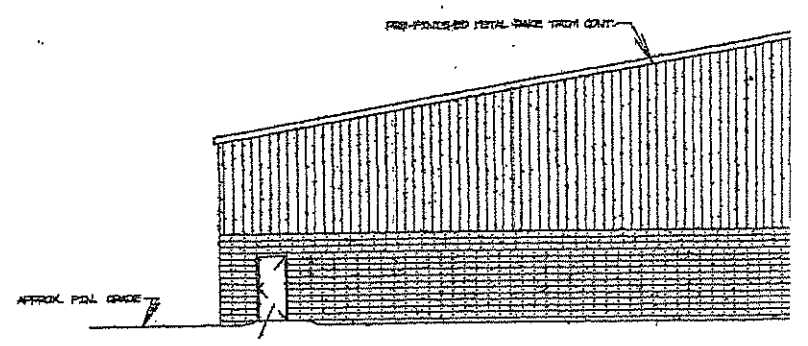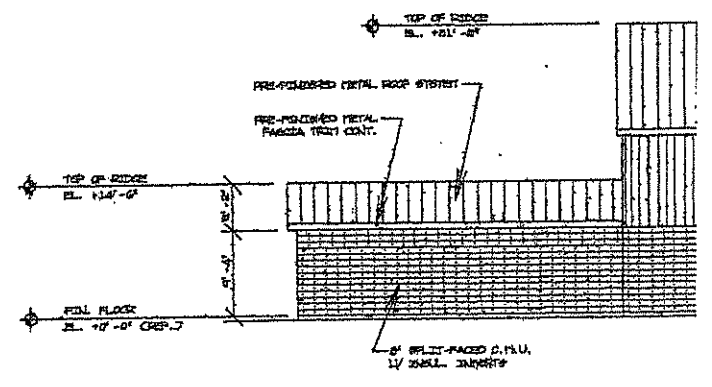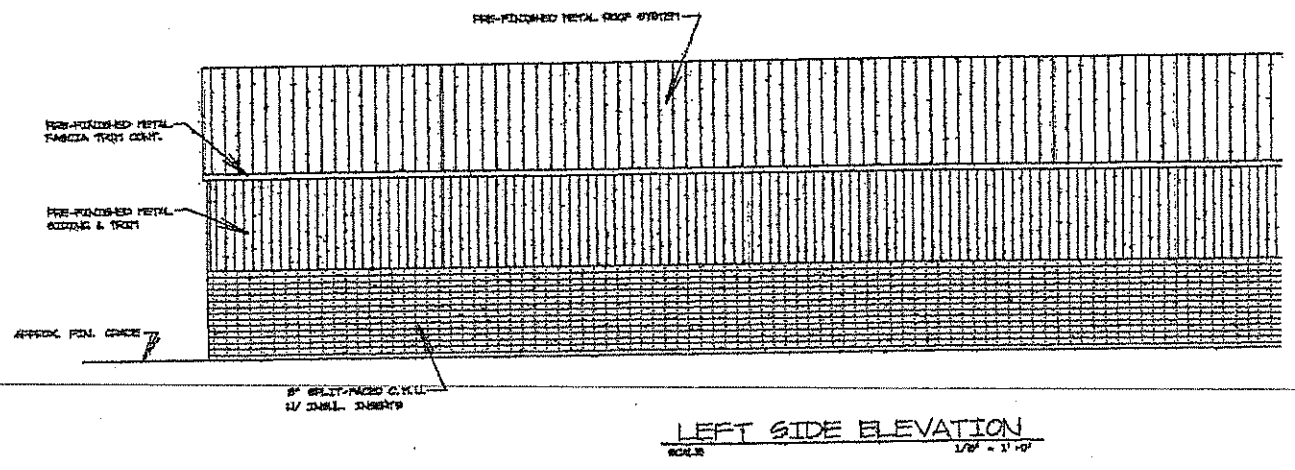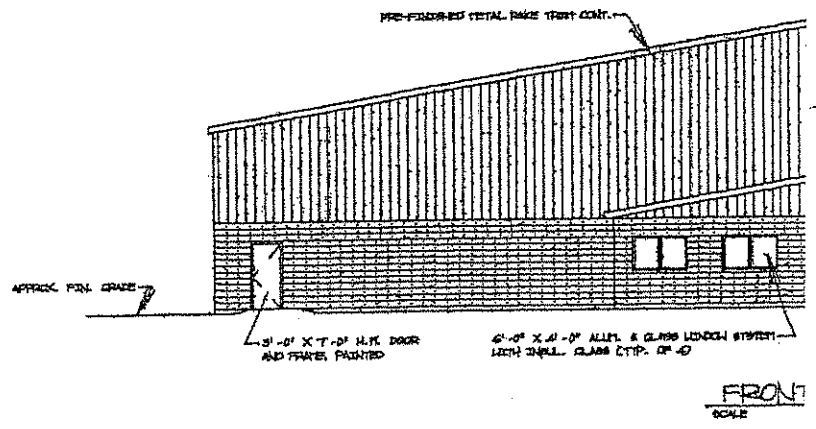

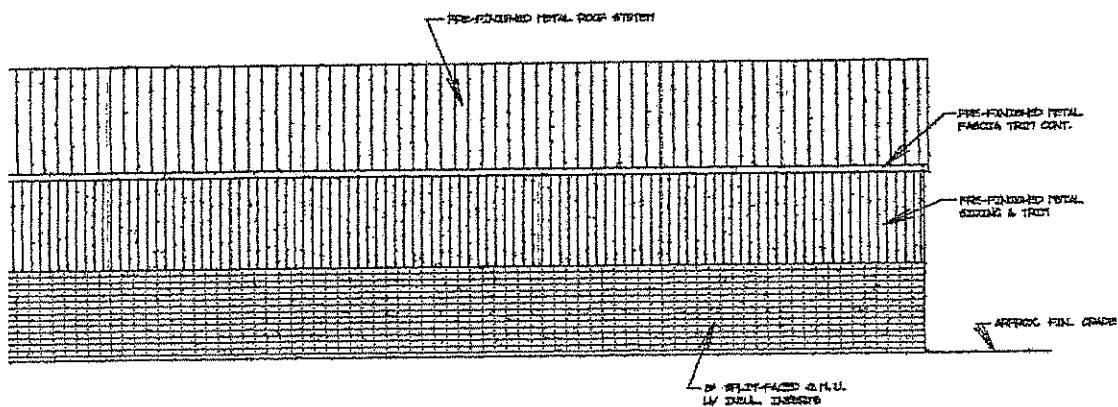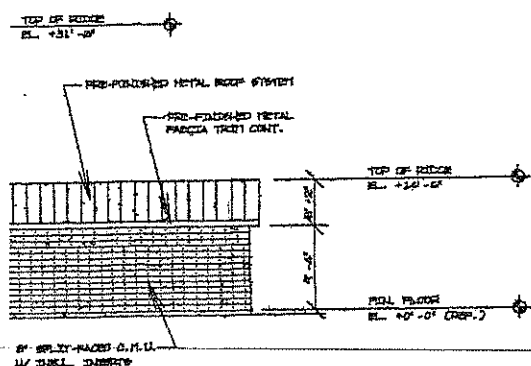

RIGHT SIDE ELEVATION

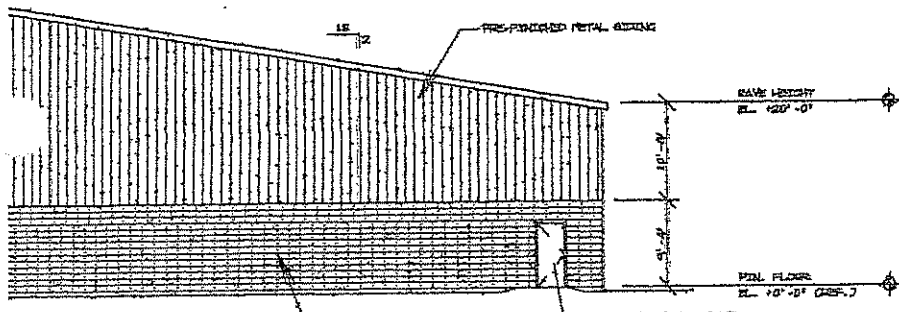

FLYNN CONSTRUCTION CORP.
COMMERCIAL & INDUSTRIAL
145 TRUMP ST., MANHATTAN, NEW YORK 10038
PHONE (904) 882-1177 FAX (904) 882-0404

[illegible]

ADVERT.

PELHAM PARKS & RECREATION
PELHAM, NEW HAMPSHIRE
VETERANS' PARK.

ELEVATIONS

DATE:	09/07/78	CREATED:
UN. QY	1	Y 11
AS NOTED		
FILED		
FILE NO.		

